



# HALL-04

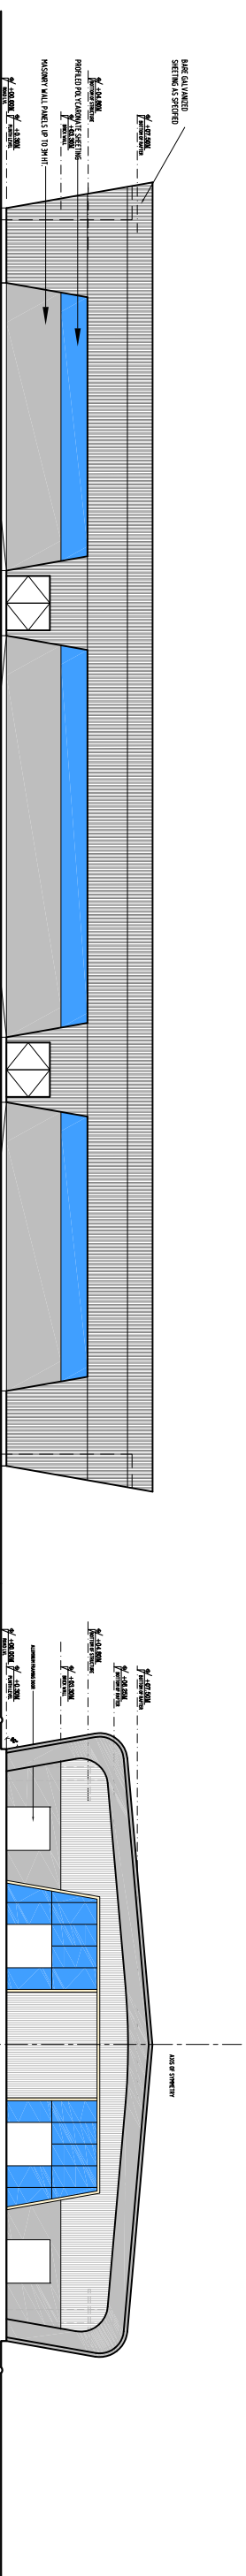


SIDE ELEVATION FOR HALL

FRONT ELEVATION

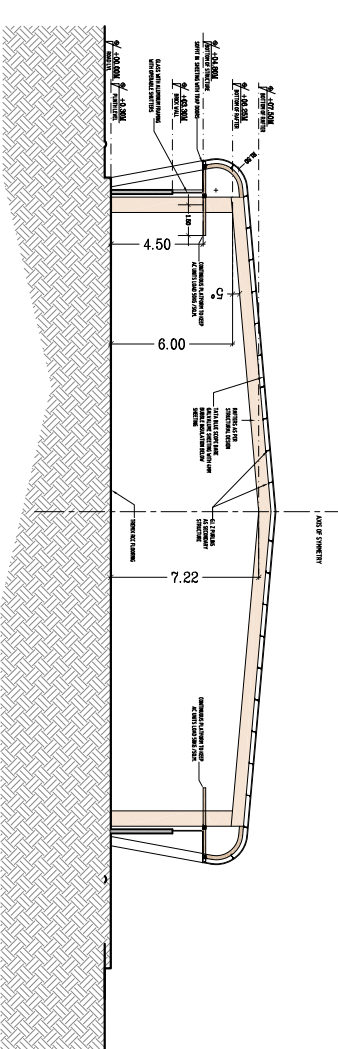

TYPICAL SECTION

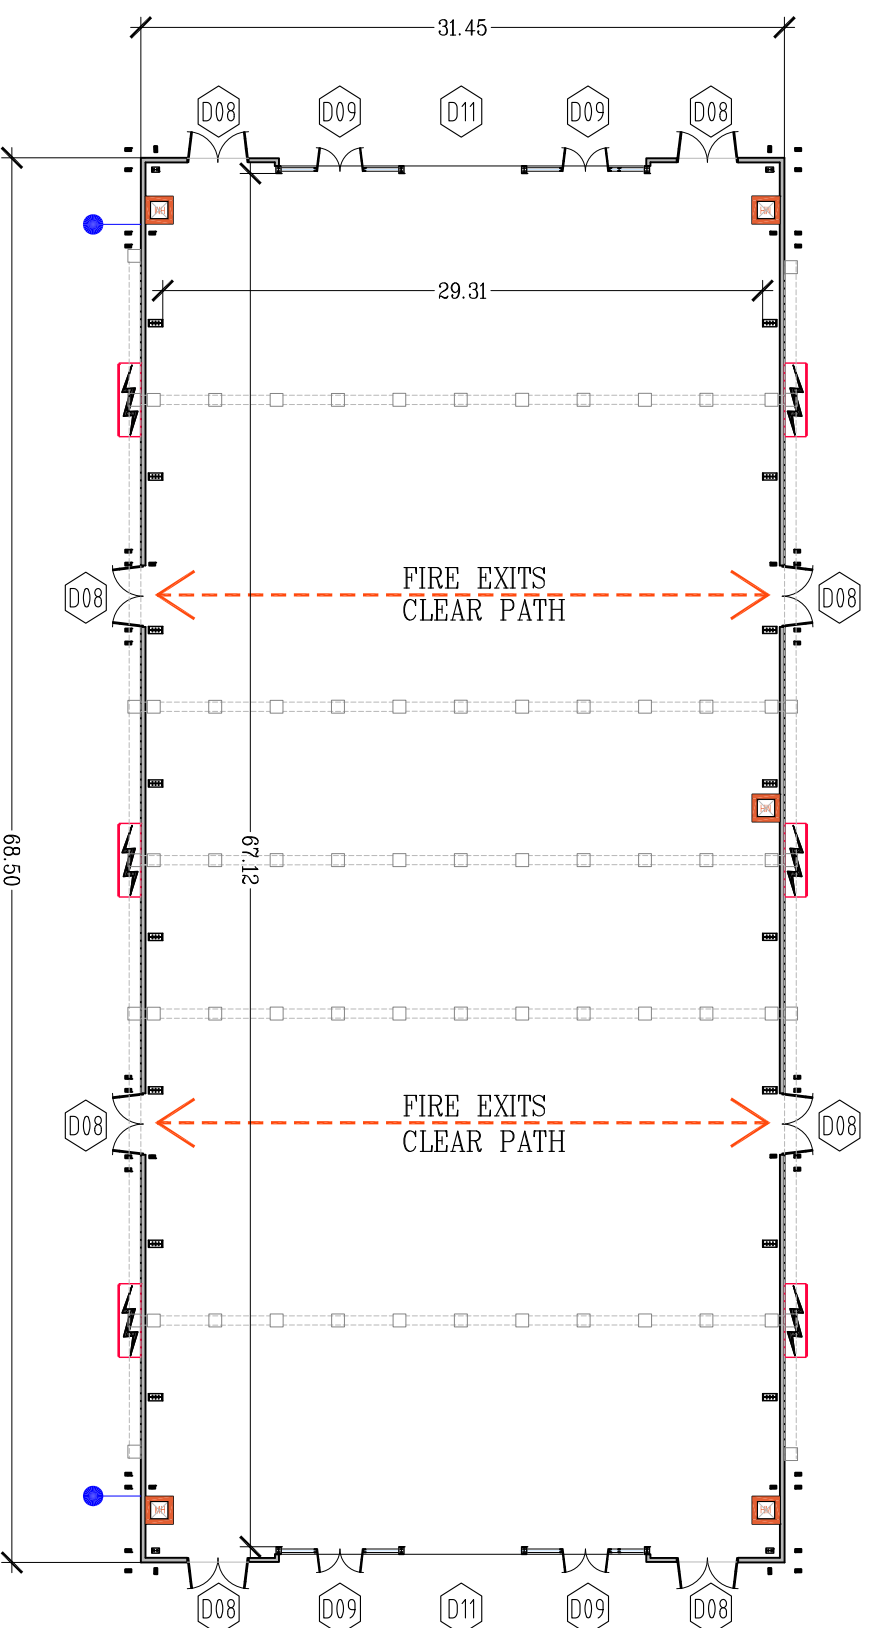

PLAN FOR HALL-04

HALL NO.	L	W	DIA	H	AREA (SQ.M.)
4	68.50	31.49	6.00		2157.07

DOOR SCHEDULE FOR EXHIBITION HALLS	WIDTH	HEIGHT	DISCUSSION
D1	8.50	8.00	TWO SIDE SLIDING DOORS
D2	8.50	7.50	ROLLING SHUTTER
D3	8.50	7.50	TWO SIDE SLIDING DOORS
D4	8.50	6.00	TWO SIDE SLIDING DOORS
D5	6.00	8.00	TWO SIDE SLIDING DOORS
D6	4.50	4.70	TWO SIDE SLIDING DOORS
D7	3.00	4.70	ROLLING SHUTTER
D8	3.00	2.40	ALUMINIUM GLASS DOOR
D9	2.40	2.40	ALUMINIUM GLASS DOOR
D10	4.50	4.70	ROLLING SHUTTER
D11	5.75	5.00	TWO SIDE SLIDING DOORS

**LEGENDS**

- ELECTRICAL TRENCHES WITH MANHOLE
- STRUCTURAL COLUMN BASE PLATE 700MM X 350MM
- MANHOLE FOR DRAINAGE
- ELECTRICAL PANELS
- WATER SUPPLY CONNECTION

REVISION	DATE	REVISION DESCRIPTION	DESIGN
			CHECKED

NOTES

CLIENT

CONSULTANTS

SIGNATURE

PROJECT CODE

EXHIBITION HALL TYPE-4

ARCHITECTURAL

K AND D COMMUNICATIONS LIMITED



**EXHIBITION CENTRE @ GANDHINAGAR, GUJARAT**

STATUS: FOR DESIGN

SAURACHANA STRUCON PVT LTD  
310, ASHAPUR AVENUE, OPP. HEMANGIRI FIRE STATION, VADVA CROSS ROAD, MANINAGAR, AHMEDABAD-380014. Ph: 26522119, 26522125 FAX: 079 26522176.



PROJECT NO: 1311  
DATE: 15/10/2014  
DRAWN BY: KP  
CHECKED: KCP  
APPROVED: KUSHI C. PATEL

RAAGIN KARMAN

JHAVERI ASSOCIATES  
2, PAKHIL SOCIETY, NR. 88/1, VEALPUR, JARVA PARK, AHMEDABAD-380051  
T: 79725262 2838, Fax: 7972522 2906, Email: jhaaveriassociates@gmail.com



DATE: 15/10/2014  
DRAWN BY: KP  
CHECKED: KCP  
APPROVED: KUSHI C. PATEL

RAAGIN KARMAN

THIS DRAWING IS THE PROPERTY OF K & D RAAGIN KARMAN AND SHALL BE USED ONLY FOR THE JOB MENTIONED IN THIS DRAWING. IT SHALL NOT BE REPRODUCED, COPIED OR CIRCULATED IN ANY FORM WITHOUT THE WRITTEN PERMISSION OF FROM K & D RAAGIN KARMAN.

JHAVERI ASSOCIATES



PROJECT NO: 1311  
DATE: 15/10/2014  
DRAWN BY: KP  
CHECKED: KCP  
APPROVED: KUSHI C. PATEL

RAAGIN KARMAN

REVISION	DATE	REVISION DESCRIPTION	DESIGN
			CHECKED

NOTES

CLIENT

CONSULTANTS

SIGNATURE

PROJECT CODE

EXHIBITION HALL TYPE-4

ARCHITECTURAL

K AND D COMMUNICATIONS LIMITED



**EXHIBITION CENTRE @ GANDHINAGAR, GUJARAT**

STATUS: FOR DESIGN

SAURACHANA STRUCON PVT LTD  
310, ASHAPUR AVENUE, OPP. HEMANGIRI FIRE STATION, VADVA CROSS ROAD, MANINAGAR, AHMEDABAD-380014. Ph: 26522119, 26522125 FAX: 079 26522176.



PROJECT NO: 1311  
DATE: 15/10/2014  
DRAWN BY: KP  
CHECKED: KCP  
APPROVED: KUSHI C. PATEL

RAAGIN KARMAN

THIS DRAWING IS THE PROPERTY OF K & D RAAGIN KARMAN AND SHALL BE USED ONLY FOR THE JOB MENTIONED IN THIS DRAWING. IT SHALL NOT BE REPRODUCED, COPIED OR CIRCULATED IN ANY FORM WITHOUT THE WRITTEN PERMISSION OF FROM K & D RAAGIN KARMAN.

JHAVERI ASSOCIATES



PROJECT NO: 1311  
DATE: 15/10/2014  
DRAWN BY: KP  
CHECKED: KCP  
APPROVED: KUSHI C. PATEL

RAAGIN KARMAN